

PROJECT
ZAHRA AL-NAKHEEL


OWNER




T +962 6 535 3222
F +962 6 537 3220
M +962 79 62 333 25

P 2069 Amman 11910 Jordan
E info@iconarch.net
W www.iconarch.net

ICON ♦ Architects & Engineers
أيقونة معماريون ومهندسون
المعماري نائل الجبيري ومشاركوه ♦ NAEL JNEIDI & ASSOCIATES

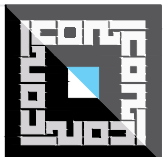



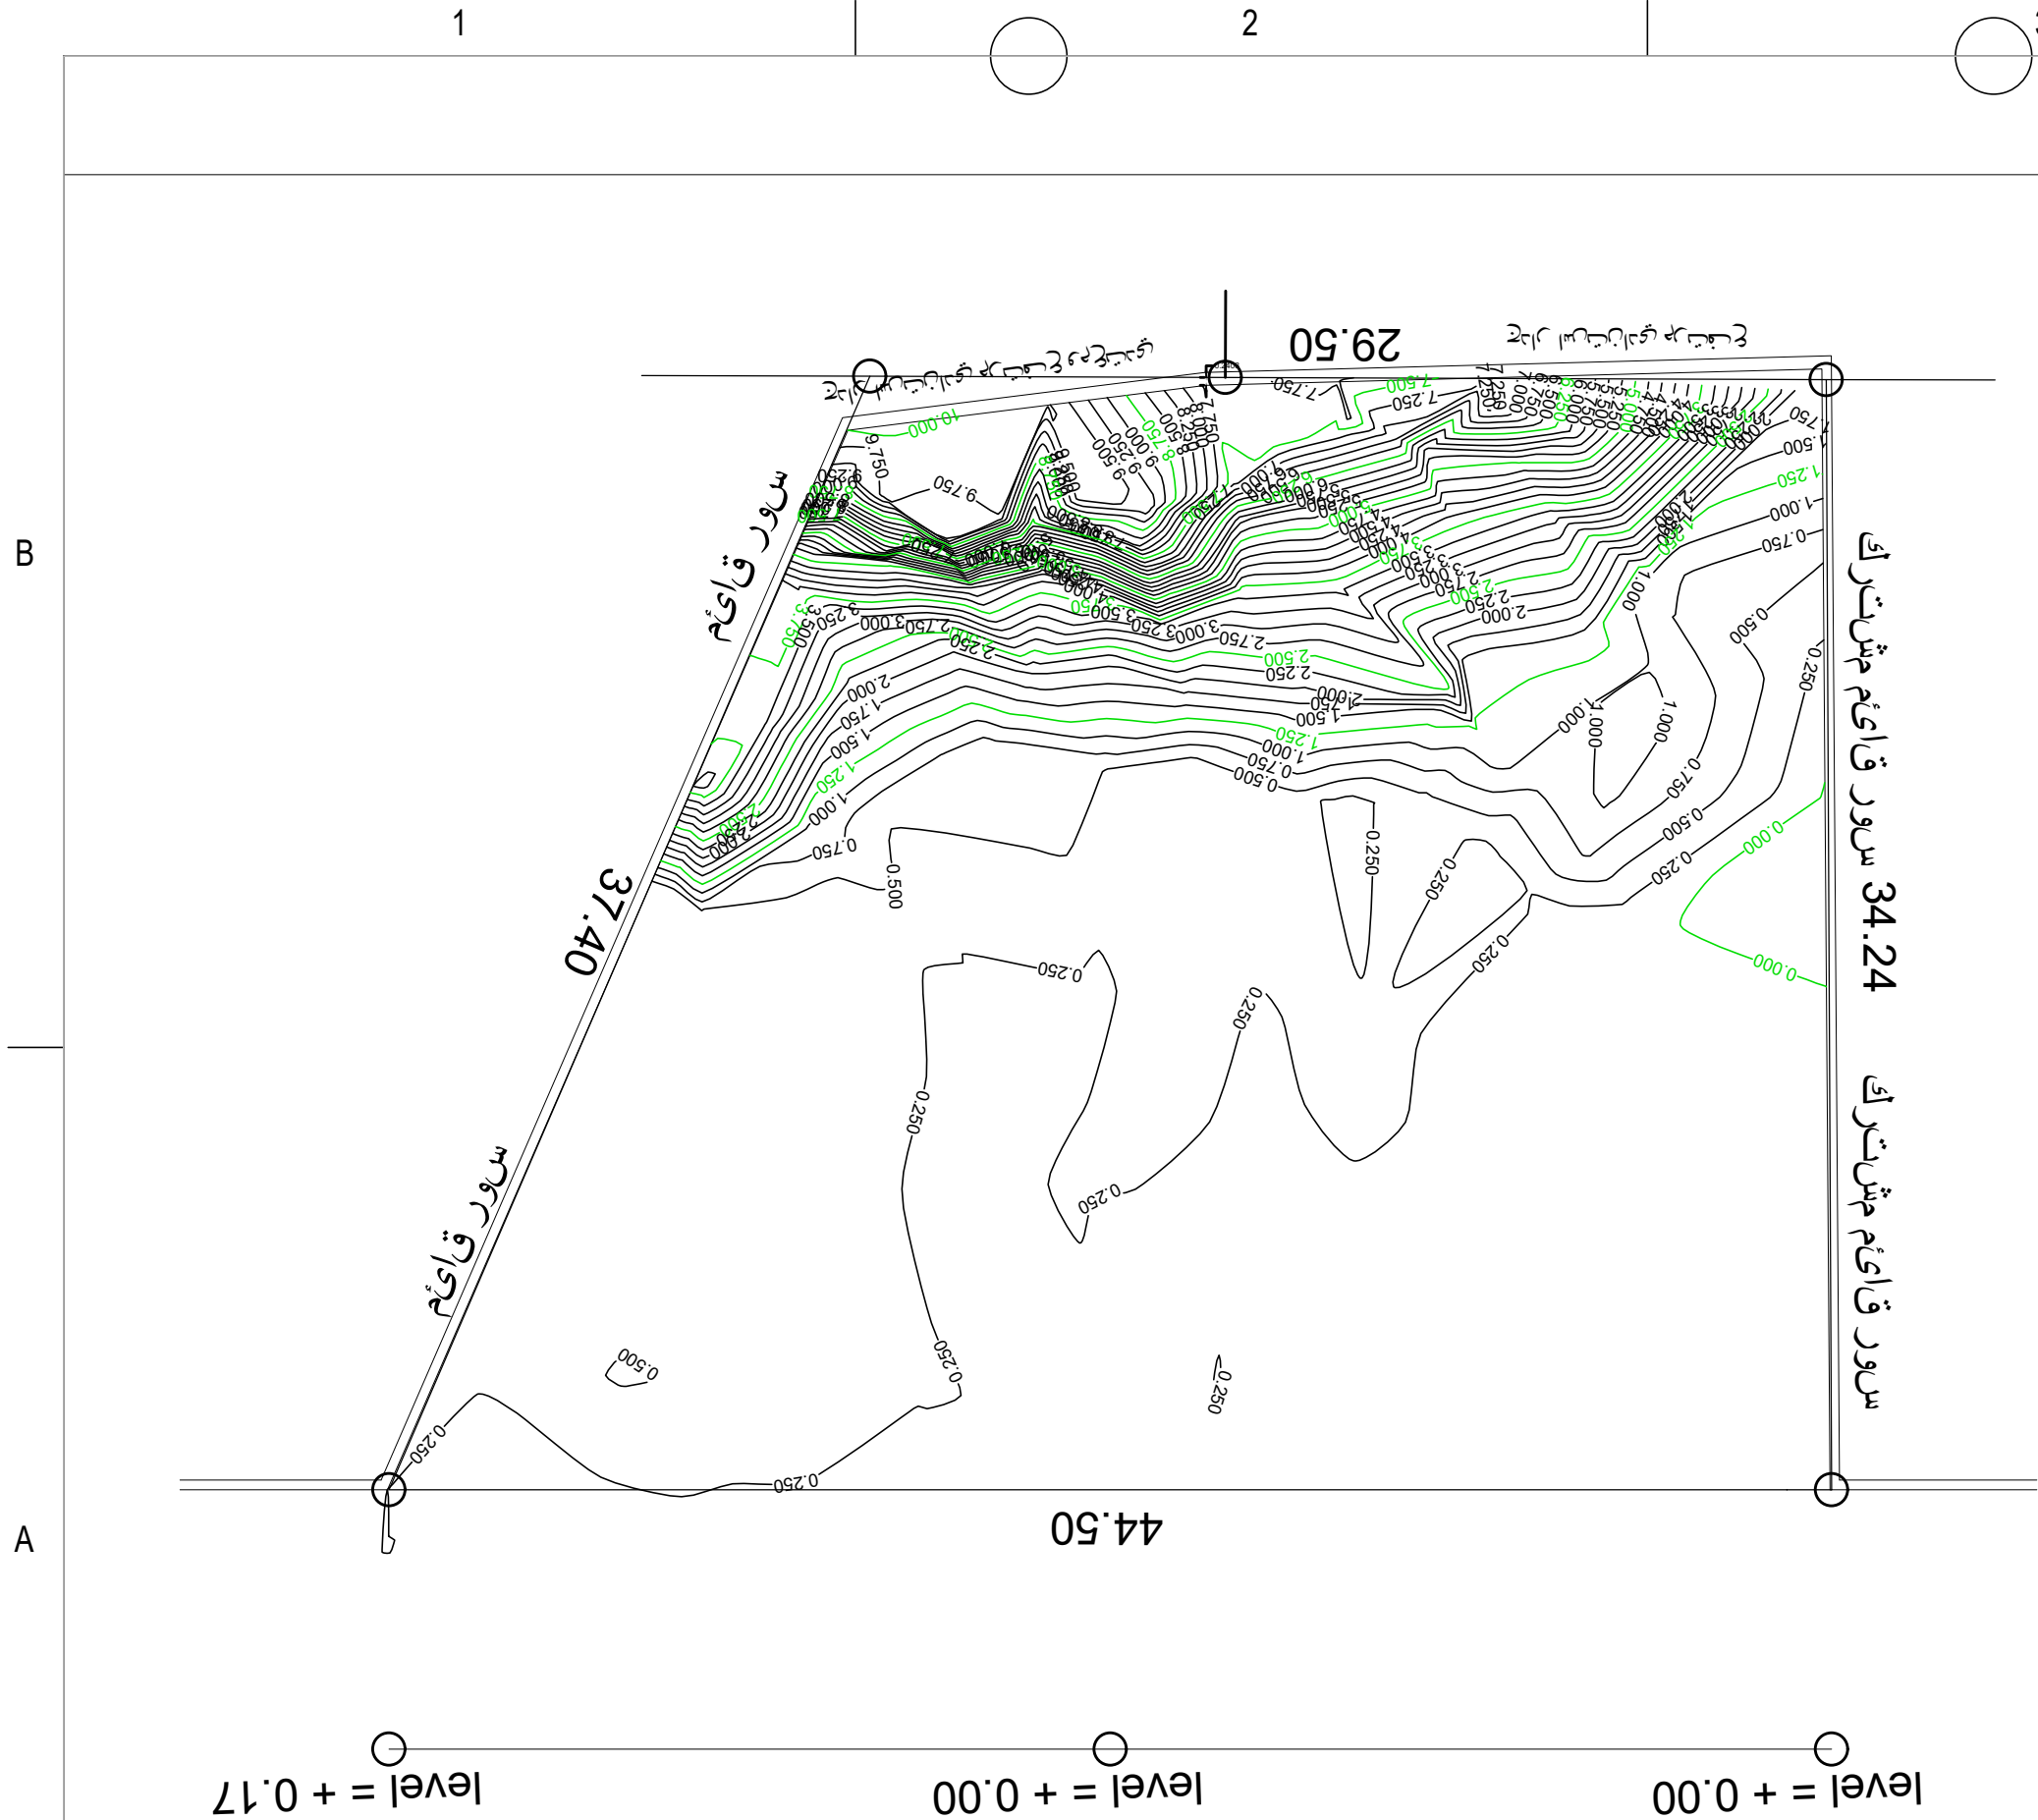

GENERAL NOTES:

1. ALL DIMENSIONS ARE IN METERS.
2. ALL LEVELS ARE IN METERS (UNLESS OTHERWISE NOTED)
3. DO NOT SCALE ANY DIMENSION, REFER TO ENGINEER FOR ANY DIMENSION CLARIFICATION OR DISCREPANCY.
4. FOR SIZES OF DOORS & WINDOWS, REFER DOOR WINDOW SCHEDULE

STAMP :

ICON LOCATION :



CONSULTANT:



ICON ♦ Consultants Engineers
الايقونة مهندسون مستشارون
Nael Jneidi & Associates ♦ النعالي والنجدي ومشاركون

Tel: +962 6 535 3222 | Cell: +962 79 62 333 25 | P.P. Box :2069 Amman
Fax: +962 6 537 3220 | info@iconarch.net | 11910 Jordan

www.iconarch.net

ELECTROMECHANICAL CONSULTANT:

KEY PLAN:



معلومات القطعة :

موقع القطعة :	
---------------	--

رقم القطعة :	
--------------	--

رقم و اسم الحوض :	
-------------------	--

	المُنظَّم
--	-----------

CLIENT:


PROJECT:

DRAWING TITLE:

SCALE:	DATE: 2018	STAGE:	
DRAWN: CAD	DESIGN: N.JINEAD 4156	CHECKED: M.SAUDI 6931	APPROVED: E.MISMAR 27502

DRAWING NO.:

PAPER SIZE:	REVISION:
- A3 -	

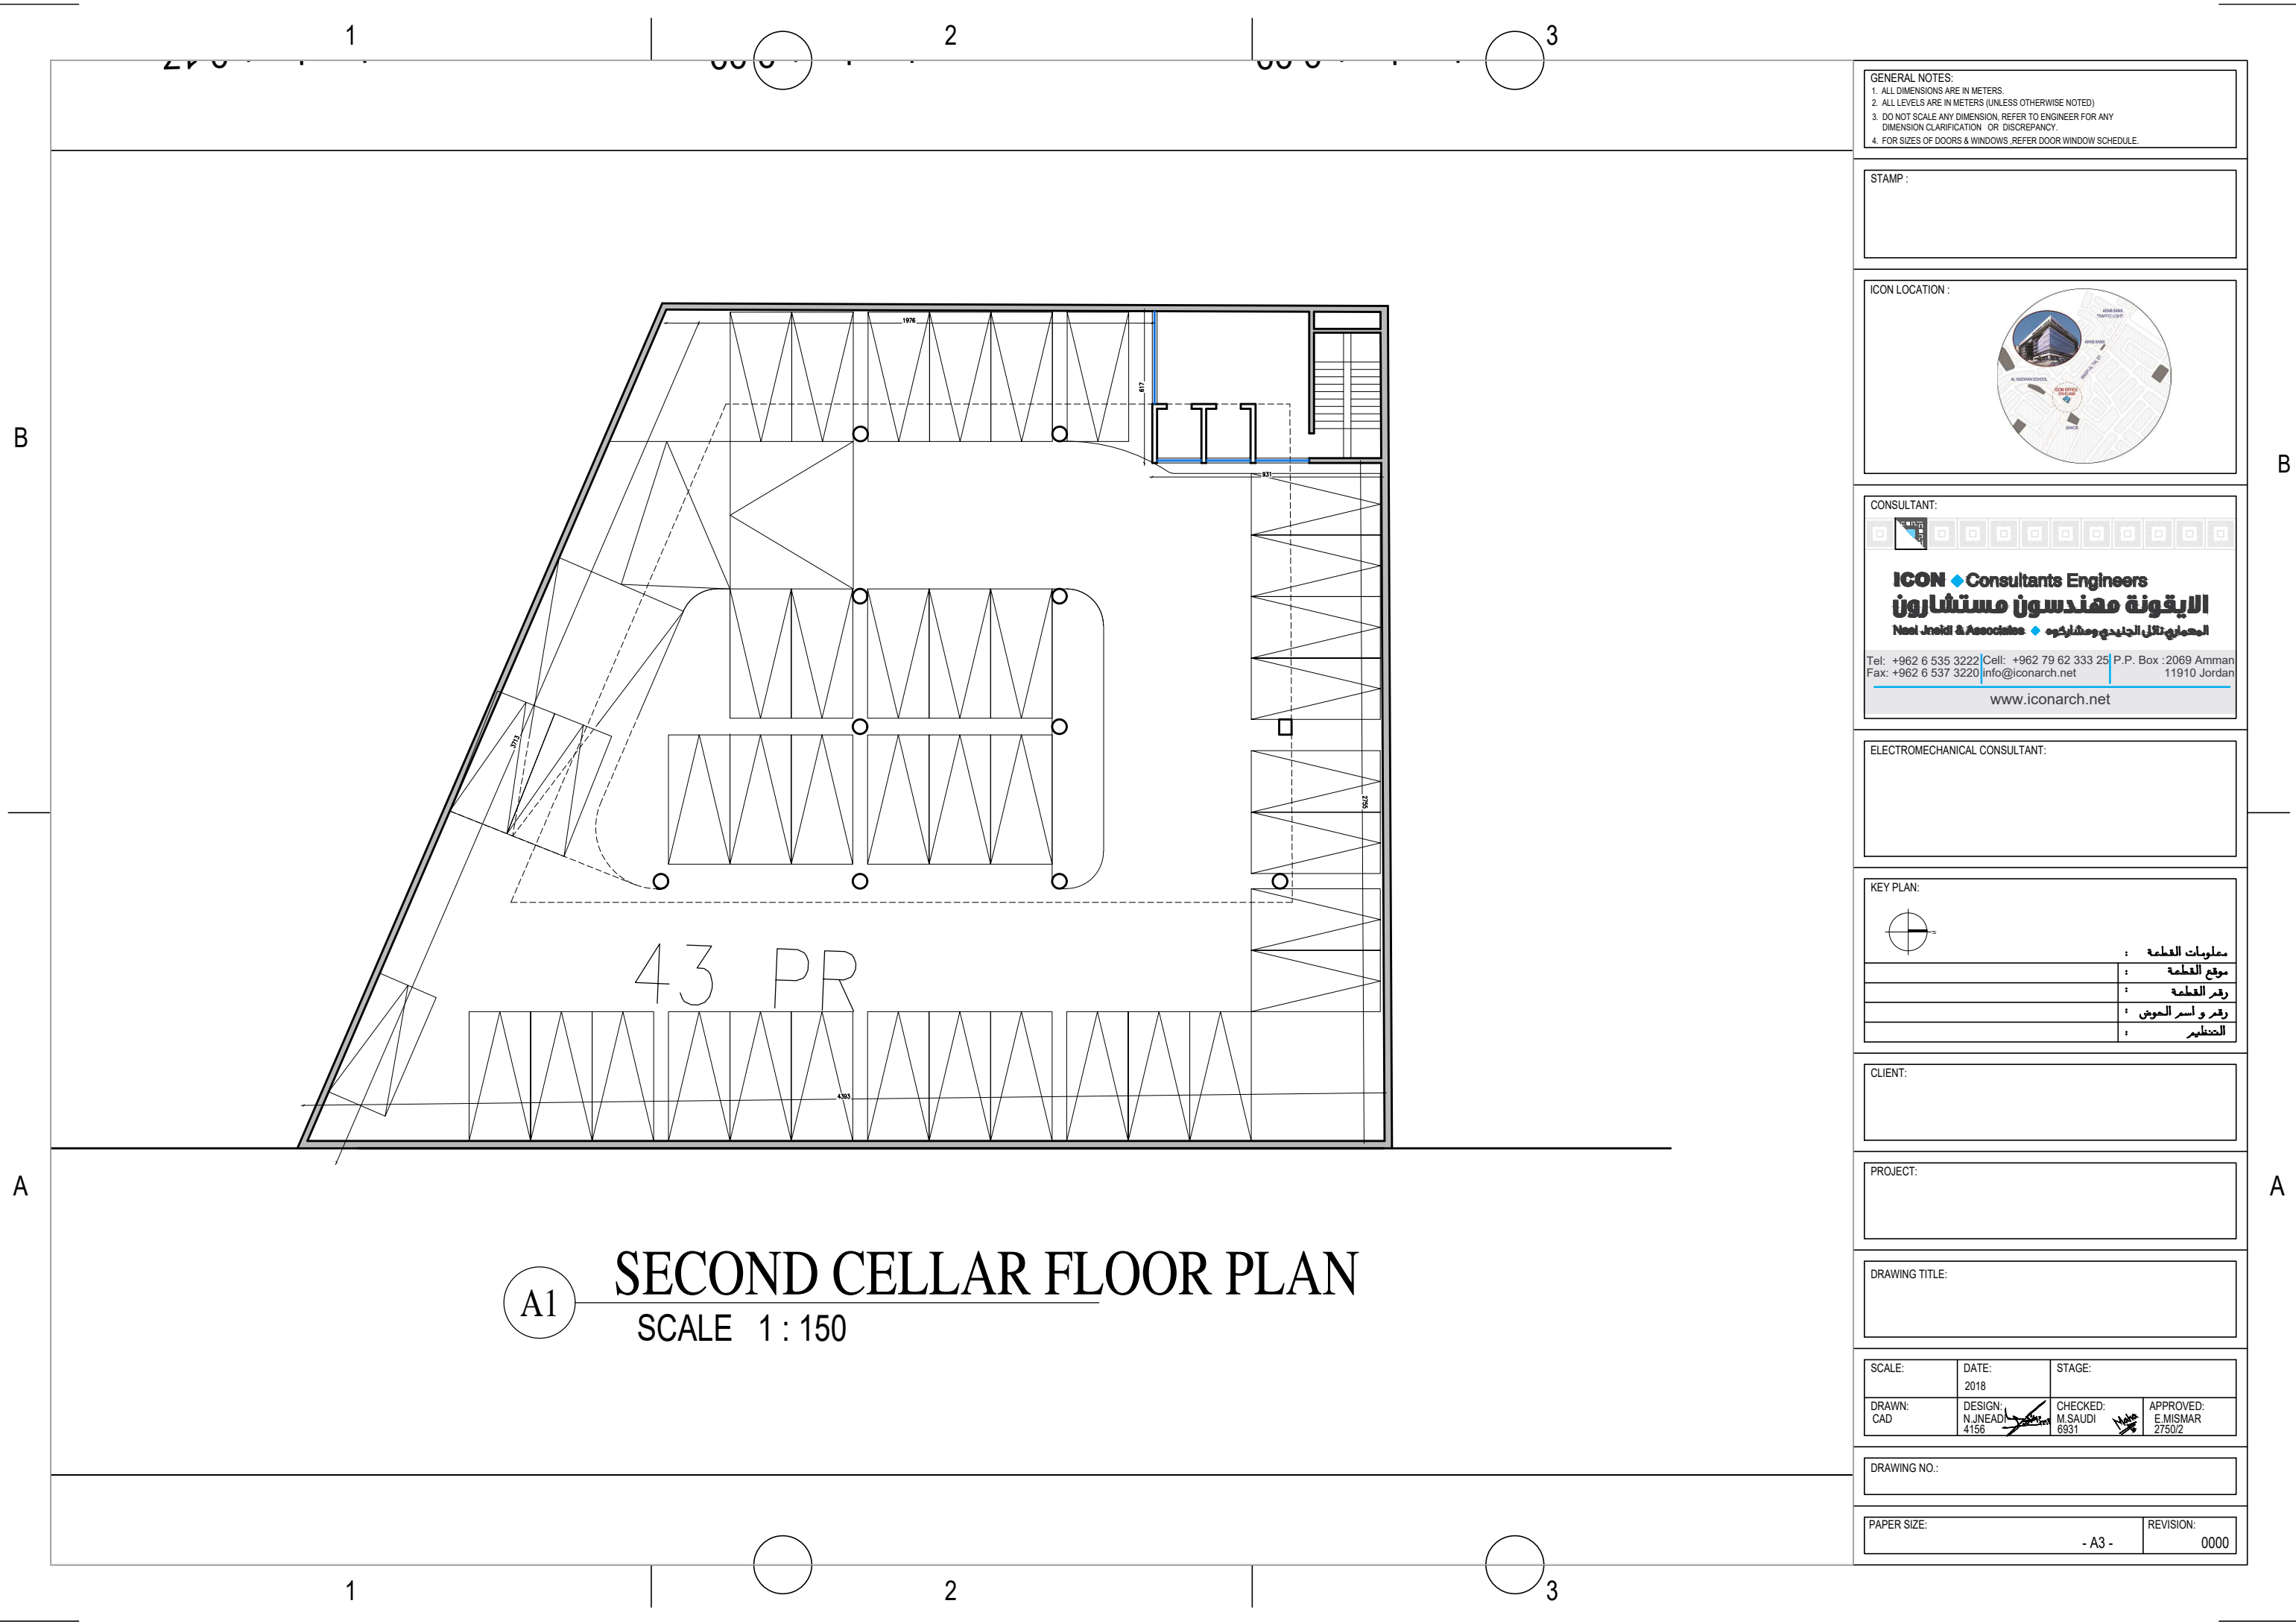

GENERAL NOTES:
1. ALL DIMENSIONS ARE IN METERS.
2. ALL LEVELS ARE IN METERS (UNLESS OTHERWISE NOTED)
3. DO NOT SCALE ANY DIMENSION, REFER TO ENGINEER FOR ANY DIMENSION CLARIFICATION OR DISCREPANCY.
4. FOR SIZES OF DOORS & WINDOWS, REFER DOOR WINDOW SCHEDULE.

STAMP :



CONSULTANT:

ICON ♦ Consultants Engineers
الايقونة مهندسون مستشارون
Neel Jneidi & Associates ♦ المعماري نائل الجنيدي ومشاركوه

Tel: +962 6 535 3222 | Cell: +962 79 62 333 25 | P.P. Box : 2069 Amman
Fax: +962 6 537 3220 | info@iconarch.net | 11910 Jordan

www.iconarch.net

ELECTROMECHANICAL CONSULTANT:

KEY PLAN:

	معلومات القطعة :
	موقع القطعة :
	رقم القطعة :
	رقم واسم الحوض :
	التعليق :

CLIENT:

PROJECT:

DRAWING TITLE:


SCALE:	DATE: 2018	STAGE:
DRAWN: CAD	DESIGN: N.JNEIDI 4156	CHECKED: M.SAUDI 6931
		APPROVED: E.MISMAR 2750/2

DRAWING NO.:

PAPER SIZE: - A3 -	REVISION: 0000
-----------------------	-------------------




PAPER SIZE:	REVISION:
- A3 -	0000

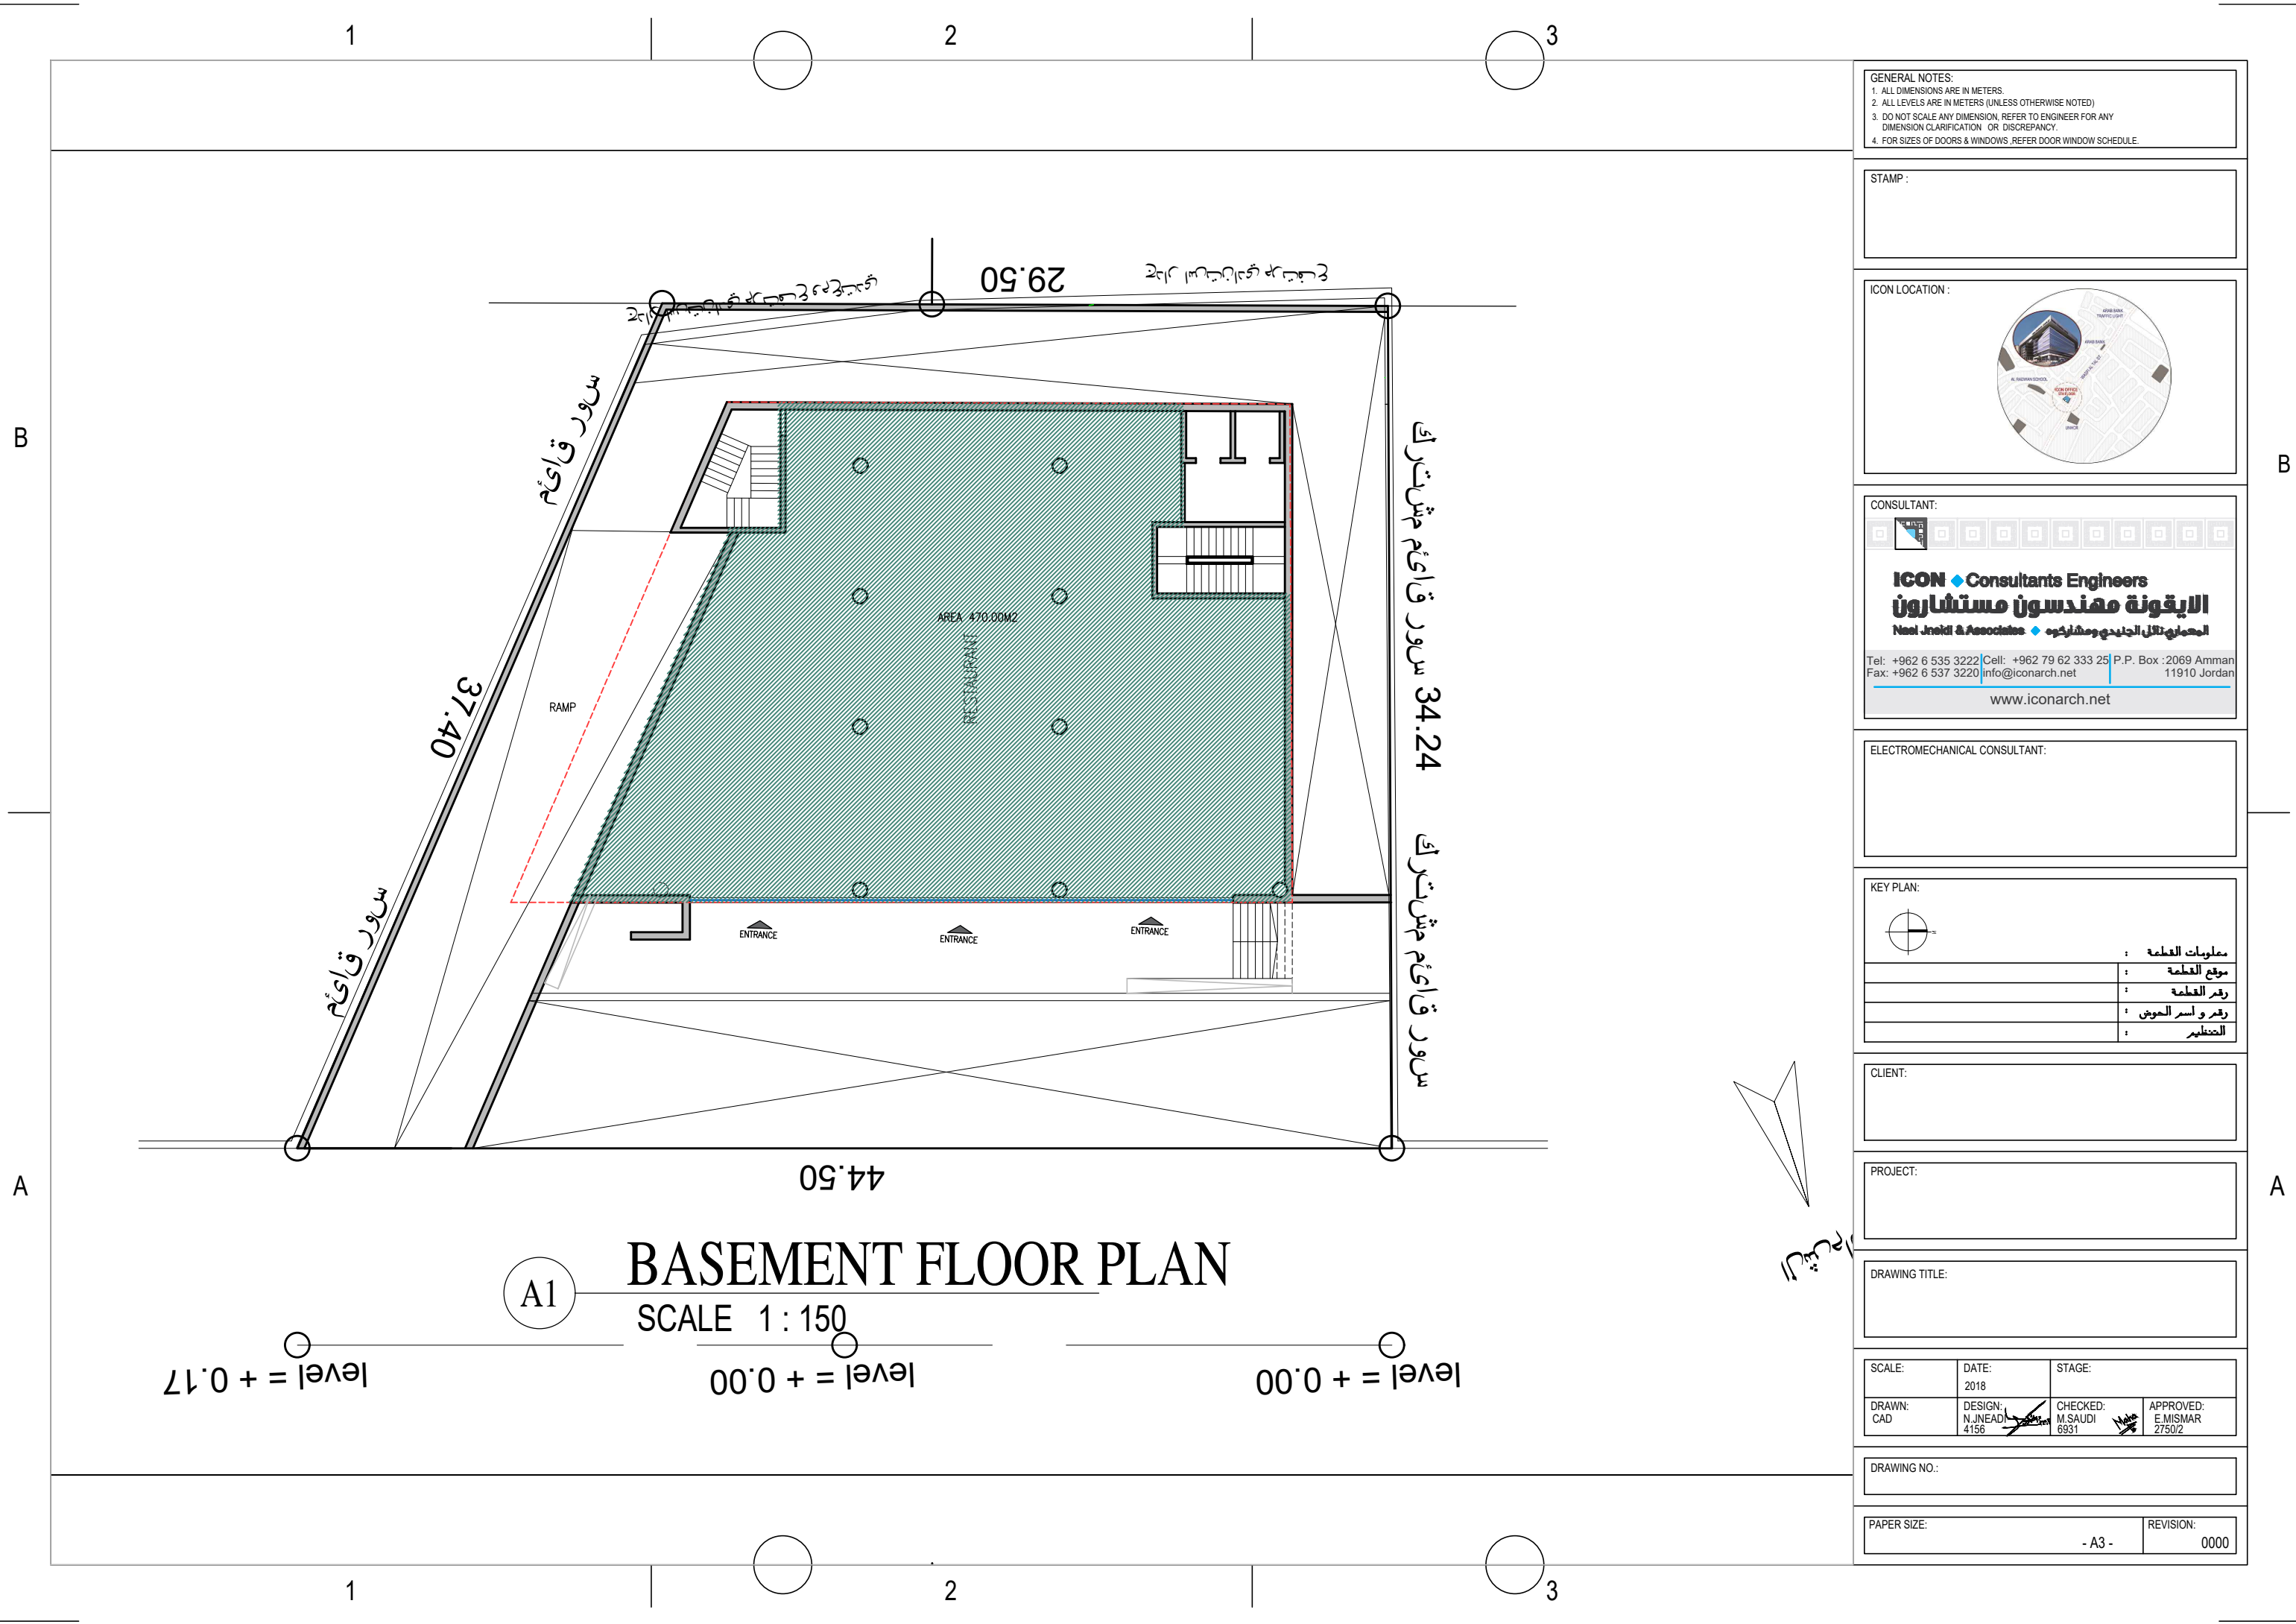

GENERAL NOTES:
1. ALL DIMENSIONS ARE IN METERS.
2. ALL LEVELS ARE IN METERS (UNLESS OTHERWISE NOTED)
3. DO NOT SCALE ANY DIMENSION, REFER TO ENGINEER FOR ANY DIMENSION CLARIFICATION OR DISCREPANCY.
4. FOR SIZES OF DOORS & WINDOWS, REFER DOOR WINDOW SCHEDULE.

STAMP :

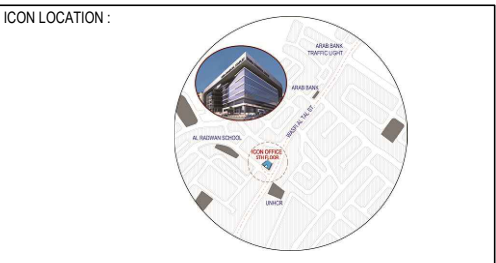

CONSULTANT:

ICON Consultants Engineers
الايقونة مهندسون مستشارون
المهندسون تالال الجندى ومشاركونه
Neel Jneidi & Associates

Tel: +962 6 535 3222 Cell: +962 79 62 333 25 P.P. Box : 2069 Amman
Fax: +962 6 537 3220 info@iconarch.net 11910 Jordan

www.iconarch.net

ELECTROMECHANICAL CONSULTANT:

KEY PLAN:

	معلومات القطعة :
	موقع القطعة :
	رقم القطعة :
	رقم واسم الموضع :
	المختبر :

CLIENT:

PROJECT:

DRAWING TITLE:

SCALE:	DATE: 2018	STAGE:	
DRAWN: CAD	DESIGN: N.JNEIDI 4156	CHECKED: M.SAUDI 6931	APPROVED: E.MISMAR 2750/2

DRAWING NO.:

PAPER SIZE: - A3 -	REVISION: 0000
-----------------------	-------------------

B

A

B

A

GENERAL NOTES:
1. ALL DIMENSIONS ARE IN METERS.
2. ALL LEVELS ARE IN METERS (UNLESS OTHERWISE NOTED)
3. DO NOT SCALE ANY DIMENSION. REFER TO ENGINEER FOR ANY DIMENSION CLARIFICATION OR DISCREPANCY.
4. FOR SIZES OF DOORS & WINDOWS, REFER DOOR WINDOW SCHEDULE.

STAMP :

ICON LOCATION :



CONSULTANT:



ICON ♦ Consultants Engineers
الايقونة مهندسون مستشارون
المهندسون نائل الجليلي ومشاركونه ♦ *Naal Jaleel & Associates*

Tel: +962 6 535 3222 Cell: +962 79 62 333 25 P.P. Box :2069 Amman
Fax: +962 6 537 3220 info@iconarch.net 11910 Jordan

www.iconarch.net

ELECTROMECHANICAL CONSULTANT:

KEY PLAN:



معلومات القطعة :
موقع القطعة :
رقم القطعة :
رقم واسم الموحى :
التعليق :

CLIENT:

PROJECT:


DRAWING TITLE:

SCALE:	DATE: 2018	STAGE:
DRAWN: CAD	DESIGN: N.JNEAD 4156	CHECKED: M.SAUDI 6931
		APPROVED: E.MISMAR 2750/2

DRAWING NO.:

PAPER SIZE:	REVISION:
- A3 -	0000

المشروع

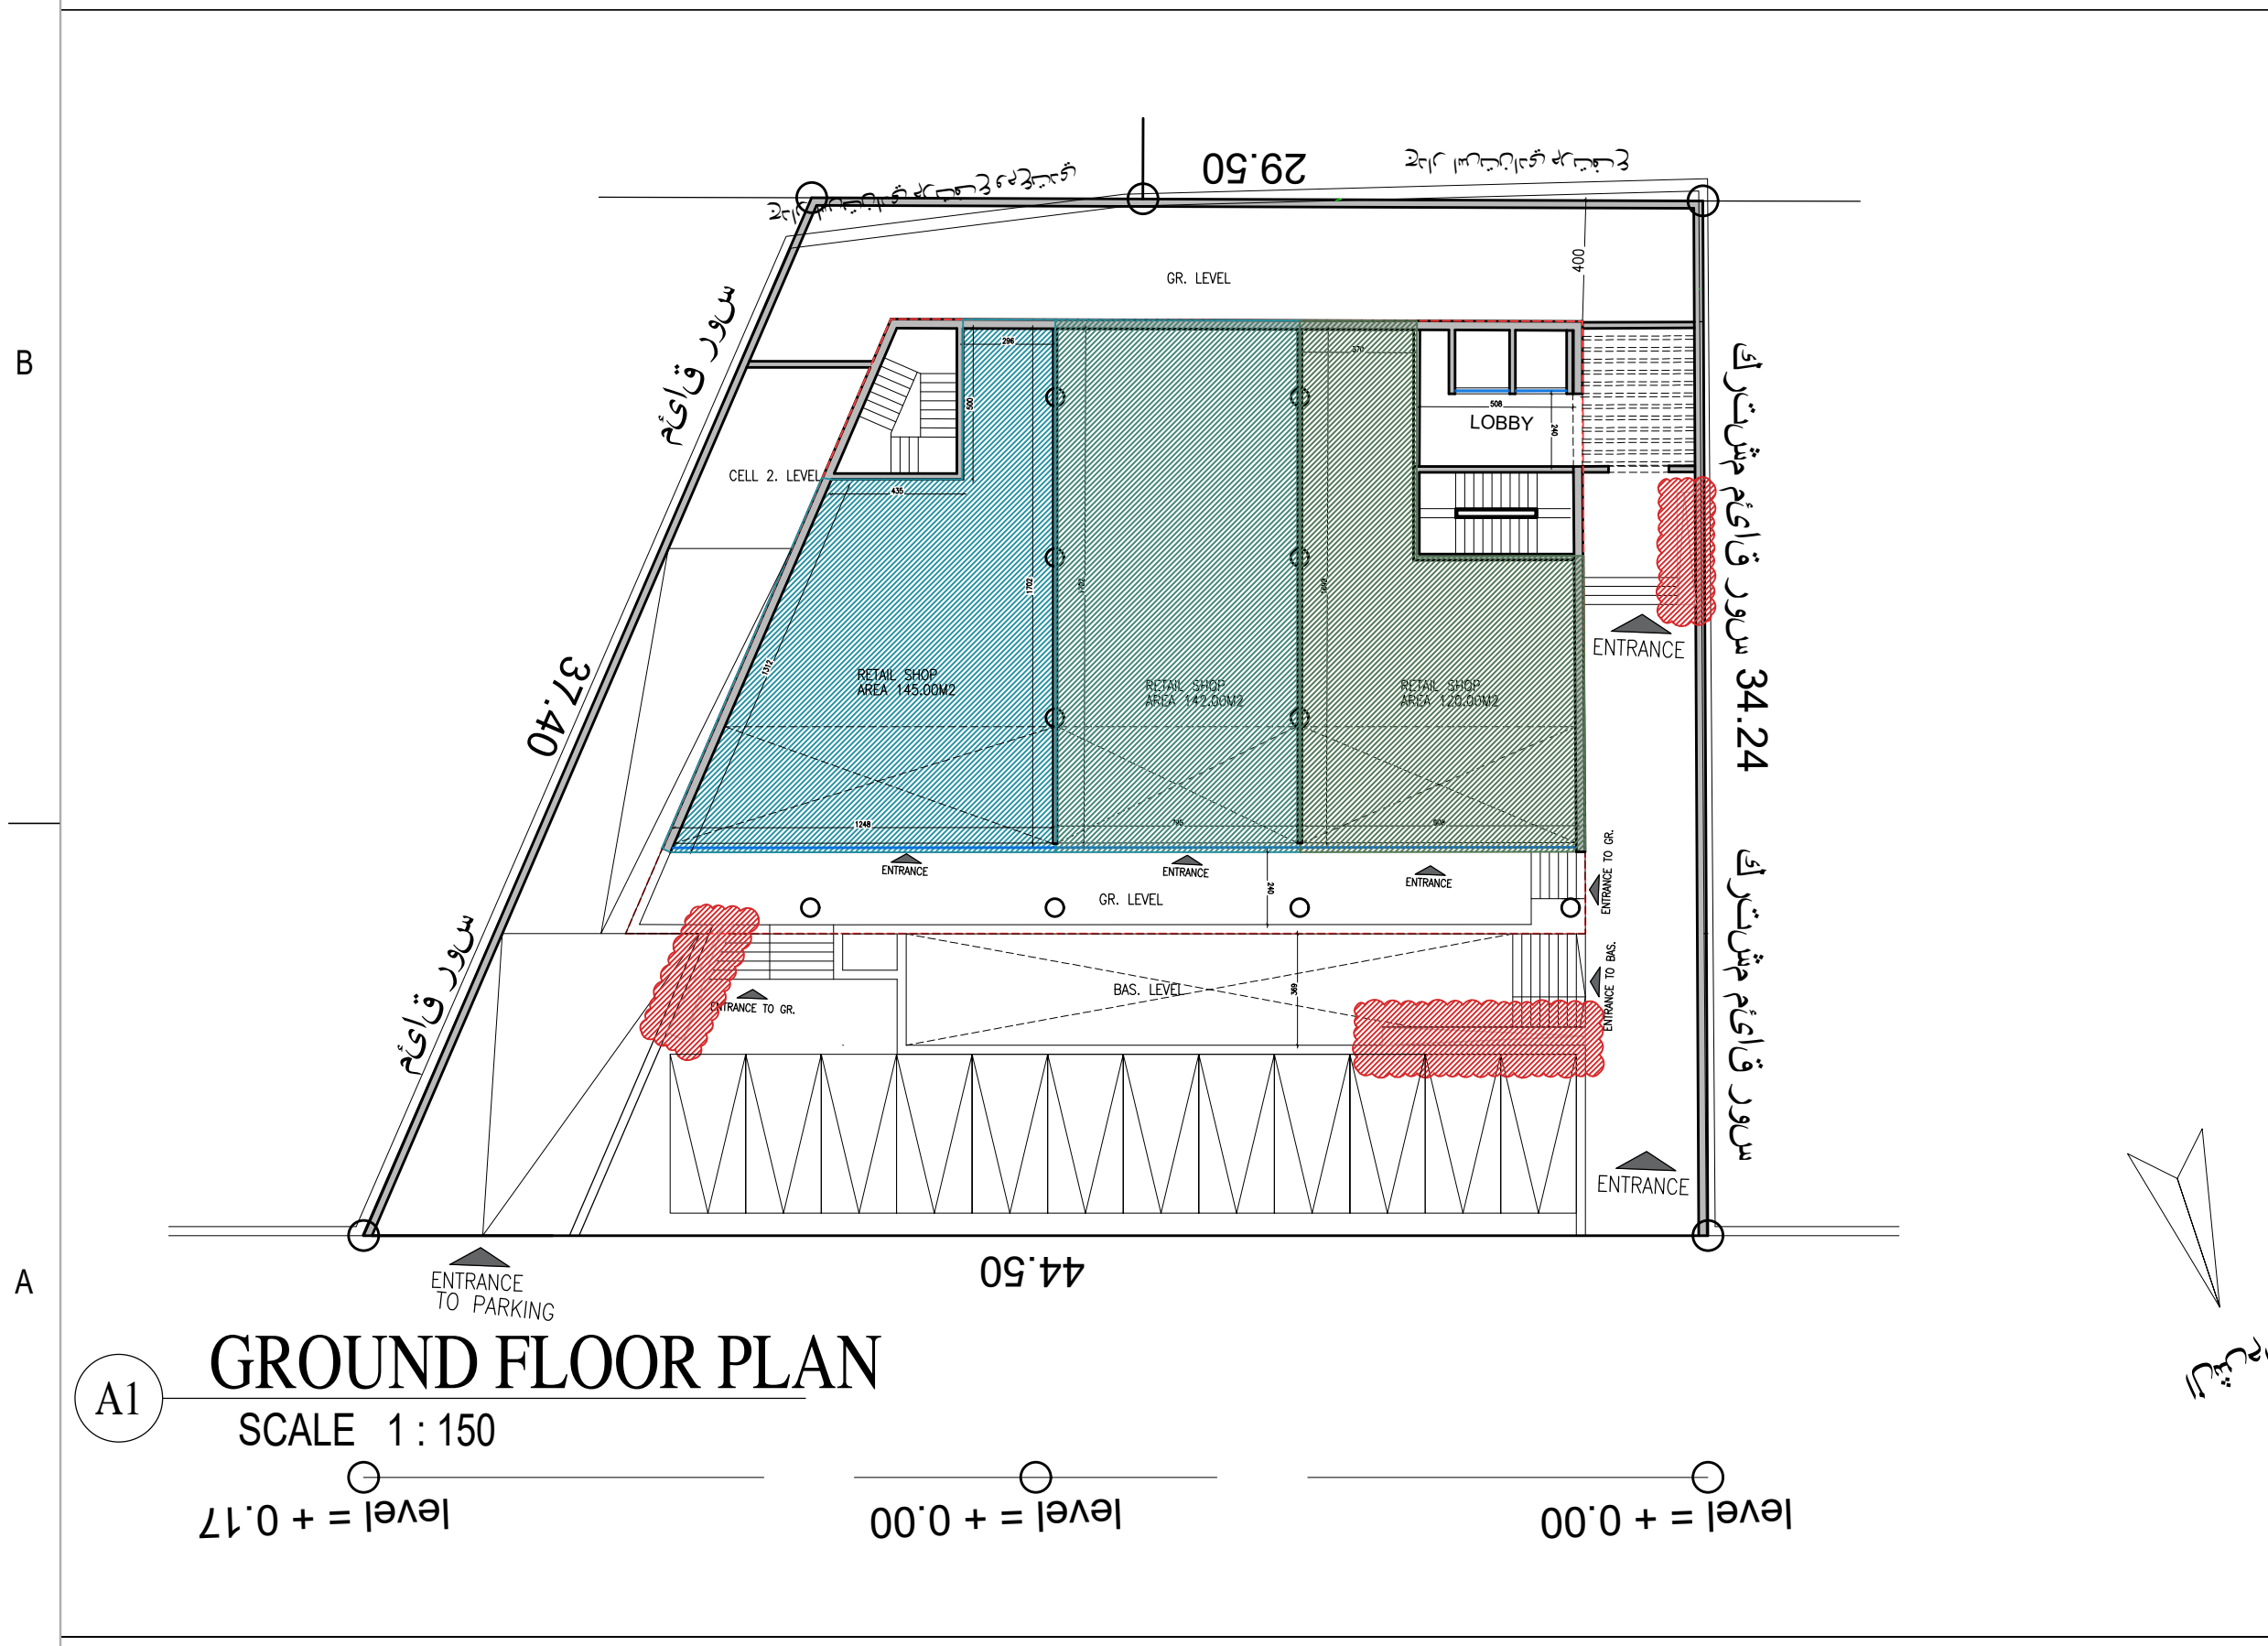

GROUND FLOOR PLAN


SCALE 1 : 150

A1

level = + 0.00 level = + 0.00 level = + 0.17

B


A

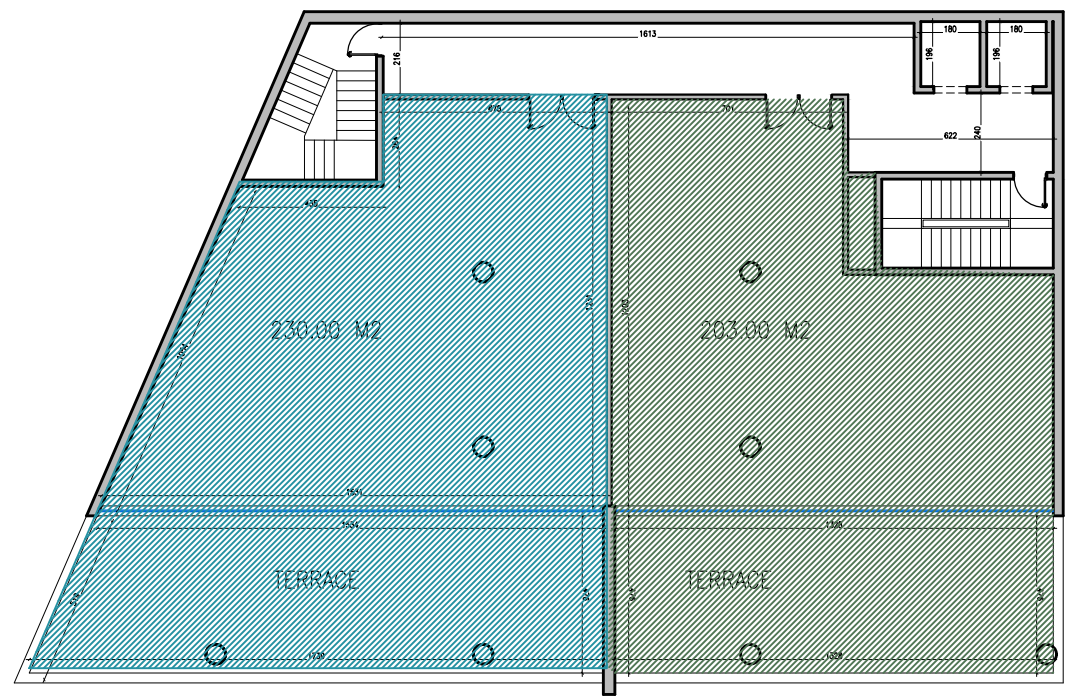

A1 FIRST FLOOR PLAN
SCALE 1 : 150

GENERAL NOTES:
1. ALL DIMENSIONS ARE IN METERS.
2. ALL LEVELS ARE IN METERS (UNLESS OTHERWISE NOTED)
3. DO NOT SCALE ANY DIMENSION, REFER TO ENGINEER FOR ANY DIMENSION CLARIFICATION OR DISCREPANCY.
4. FOR SIZES OF DOORS & WINDOWS, REFER DOOR WINDOW SCHEDULE.

STAMP :

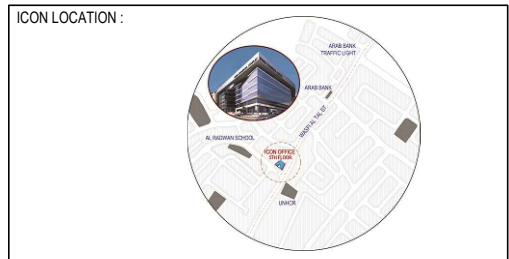

CONSULTANT:

ICON ♦ Consultants Engineers
الايقونة مهندسون مستشارون
Neel Jneidi & Associates ♦ المحامي نائل الجنيدي ومشاركونه

Tel: +962 6 535 3222 Cell: +962 79 62 333 25 P.P. Box : 2069 Amman
Fax: +962 6 537 3220 info@iconarch.net 11910 Jordan

www.iconarch.net

ELECTROMECHANICAL CONSULTANT:

KEY PLAN:

	معلومات القطعة :
	موقع القطعة :
	رقم القطعة :
	رقم و اسم الحوض :
	المتنظير :

CLIENT:

PROJECT:

DRAWING TITLE:


SCALE:	DATE: 2018	STAGE:
DRAWN: CAD	DESIGN: N.JNEIDI 4156	CHECKED: M.SAUDI 6931
		APPROVED: E.MISMAR 2750/2

DRAWING NO.:

PAPER SIZE:	REVISION:
- A3 -	0000

B

A

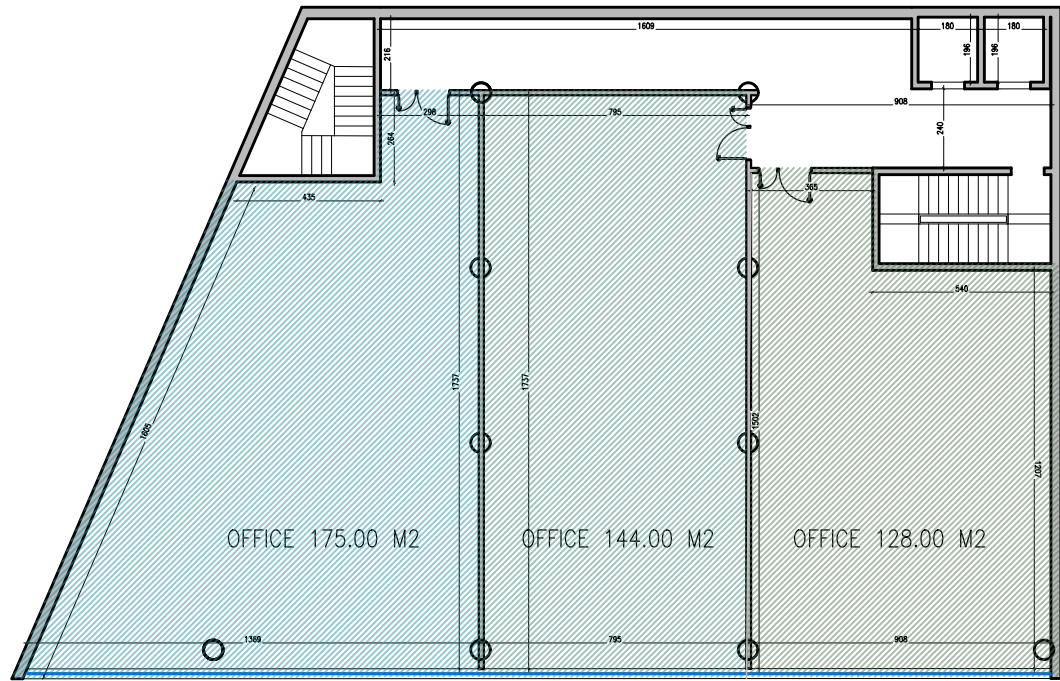

SECOND & THIRD FLOOR PLAN
SCALE 1 : 150

AREA SCHEDULE

NO.	FLOOR	SERVICES AREA	RENTABLE AREA	GROSS AREA
01	SECOND CELLAR FLOOR AREA	1284.00	0	1284.00
02	FIRST CELLAR FLOOR AREA	1284.00	0	1284.00
TOTAL				2568.00
01	BASEMENT FLOOR AREA	55.76	470.00	525.76
02	GROUND FLOOR AREA	118.76	407.00	525.76
03	MEZZ FLOOR AREA	97.00	303.00	400.00
04	FIRST FLOOR AREA	92.76	433.00	525.76
05	SECOND FLOOR AREA	78.76	447.00	525.76
06	THIRD FLOOR AREA	78.76	447.00	525.76
07	STAIRCASE & MACHINE ROOM	50.00	0	50.00
TOTAL			2507.00 M2	5 646.80 M2

GENERAL NOTES:
1. ALL DIMENSIONS ARE IN METERS.
2. ALL LEVELS ARE IN METERS (UNLESS OTHERWISE NOTED)
3. DO NOT SCALE ANY DIMENSION, REFER TO ENGINEER FOR ANY DIMENSION CLARIFICATION OR DISCREPANCY.
4. FOR SIZES OF DOORS & WINDOWS, REFER DOOR WINDOW SCHEDULE.

STAMP :

ICON LOCATION :



CONSULTANT:



ICON Consultants Engineers
الايقونة مهندسون مستشارون
Neel Jneidi & Associates ◆ **المهندسون الاستشاريون**

Tel: +962 6 535 3222 Cell: +962 79 62 333 25 P.P. Box : 2069 Amman
Fax: +962 6 537 3220 info@iconarch.net 11910 Jordan

www.iconarch.net

ELECTROMECHANICAL CONSULTANT:

KEY PLAN:



معلومات القطعة :
موقع القطعة :
رقم القطعة :
رقم واسم الموضع :
المختبر :

CLIENT:

PROJECT:

DRAWING TITLE:

SCALE:	DATE: 2018	STAGE:	
DRAWN: CAD	DESIGN: N.JNEIDI 4156	CHECKED: M.SAUDI 6931	APPROVED: E.MISMAR 2750/2

DRAWING NO.:

PAPER SIZE:	REVISION:
- A3 -	0000